

RUSH SOUTH OIL & GAS WELL

4-65 29-30 3AH, 1V, 3BH, 3CH, 3DH, 4AH, 4BH, 4CH, 4DH

SECTION 28, TOWNSHIP 4 SOUTH, RANGE 65 WEST OF THE SIXTH PRINCIPAL  
MERIDIAN, CITY OF AURORA, ARAPAHOE COUNTY, STATE OF COLORADO

LATITUDE = 39°40'18.21"N, LONGITUDE = 104°40'37.59"W

2464 S. POWHATON RD 80018




KAZIN & ASSOCIATES, INC  
CONSULTING  
ELECTRICAL ENGINEERS

9364 TEDDY LANE,  
SUITE #101  
LONE TREE, CO 80124  
(720) 489-1609  
(720) 489-1611 FAX

RUSH - SOUTH

AURORA, COLORADO


LIGHTING FIXTURE SCHEDULE							
PREPARED BY KAZIN & ASSOCIATES							
DESCRIPTION OF LUMINAIRE				BASIS OF DESIGN			
ID	DESCRIPTION	FINISH	MOUNTING INFO	MANUFACTURER	CATALOG NUMBER	LOAD (VA)	TOTAL LUMENS
4	4 HEAD FLOOD LIGHT LED MOBILE TEMPORARY LIGHTING TOWER	STD	25' TOWER	XX	XX	4 @ 350W	215,276

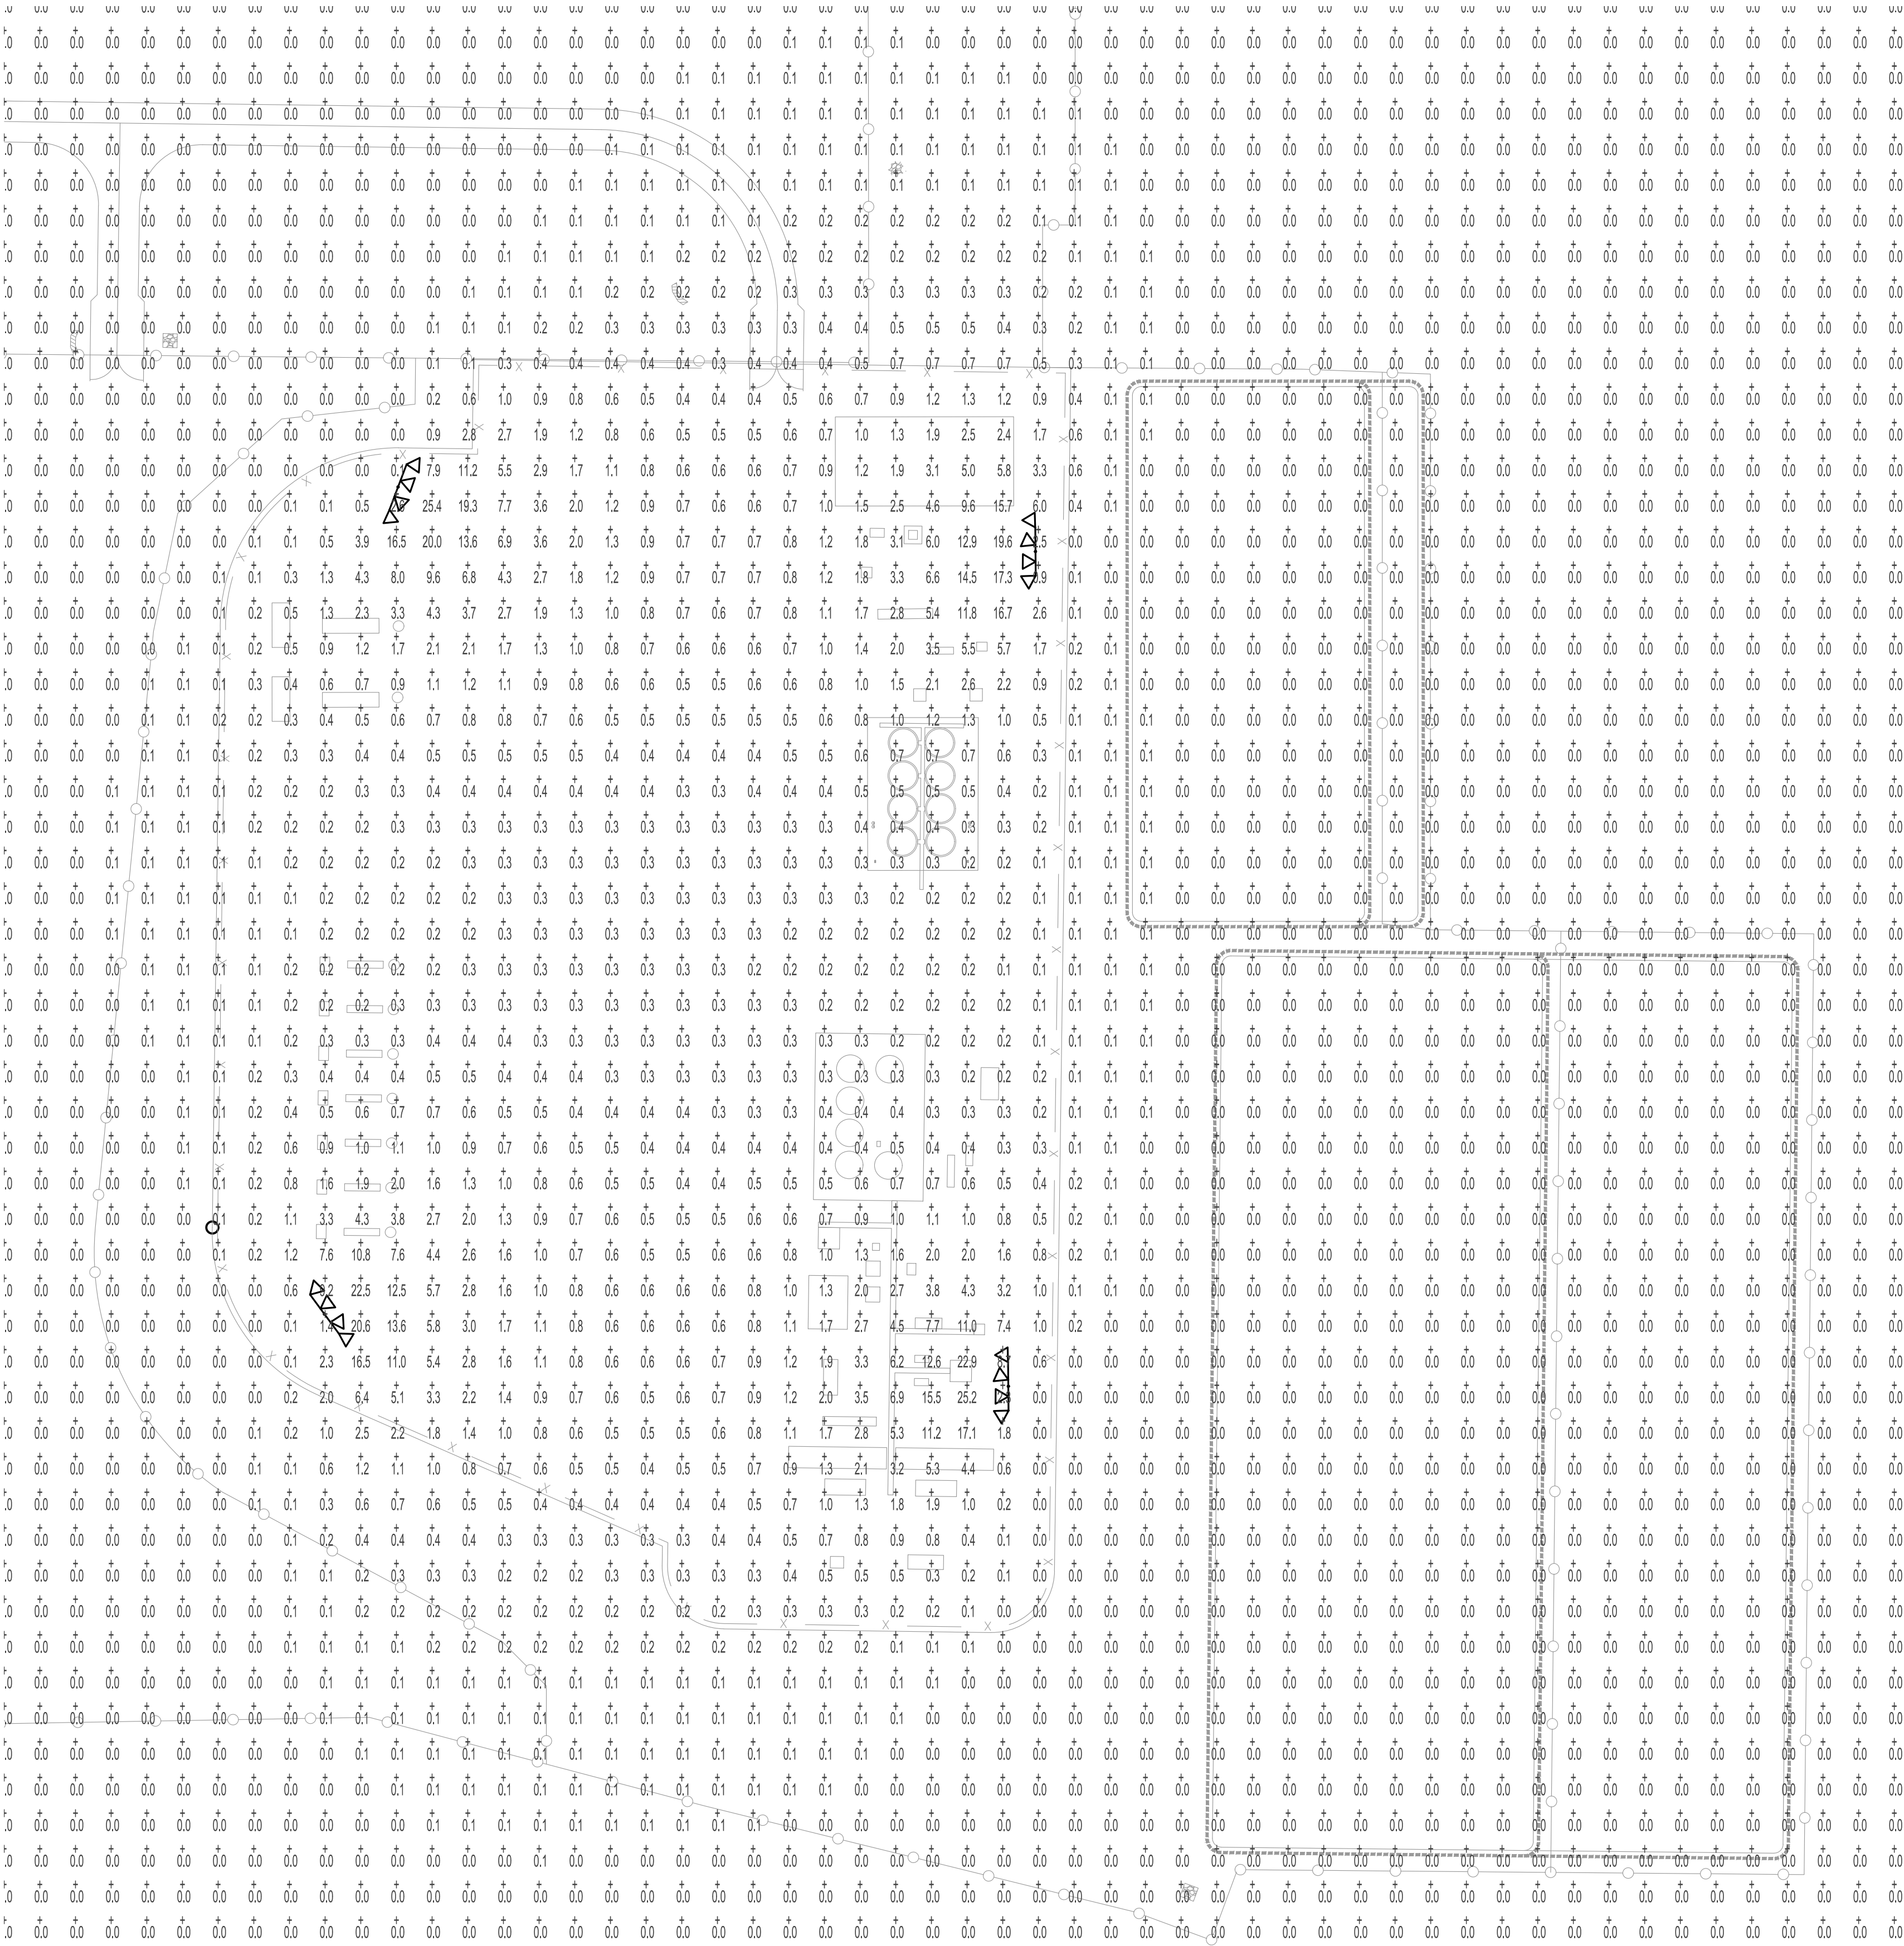

CLIENT:  
CONOCOPHILLIPS

Project Number SOUTH  
Date 7-1-19  
Drawn by DMK  
Checked by DMK

4-65 29-30 3AH, 1V, 3BH, 3CH, 3DH, 4AH, 4BH, 4CH, 4DH  
SECTION 28, TOWNSHIP 4 SOUTH, RANGE 65 WEST OF THE SIXTH PRINCIPAL  
MERIDIAN, CITY OF AURORA, ARAPAHOE COUNTY, STATE OF COLORADO  
LATITUDE = 39°40'18.21"N, LONGITUDE = 104°40'37.59"W  
2464 S. POWHATON RD 80018

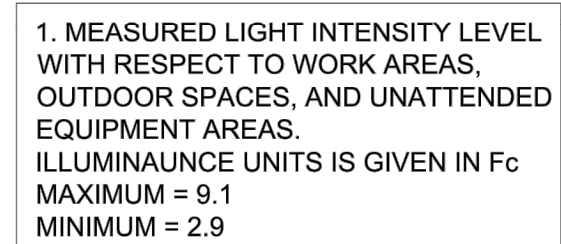

NOTES:

1. ACTUAL CONFIGURATION MAY VARY AT THIS SITE.

PH-2